


2 THIRD FLOOR PLAN
SCALE: 1/8" = 1'-0"

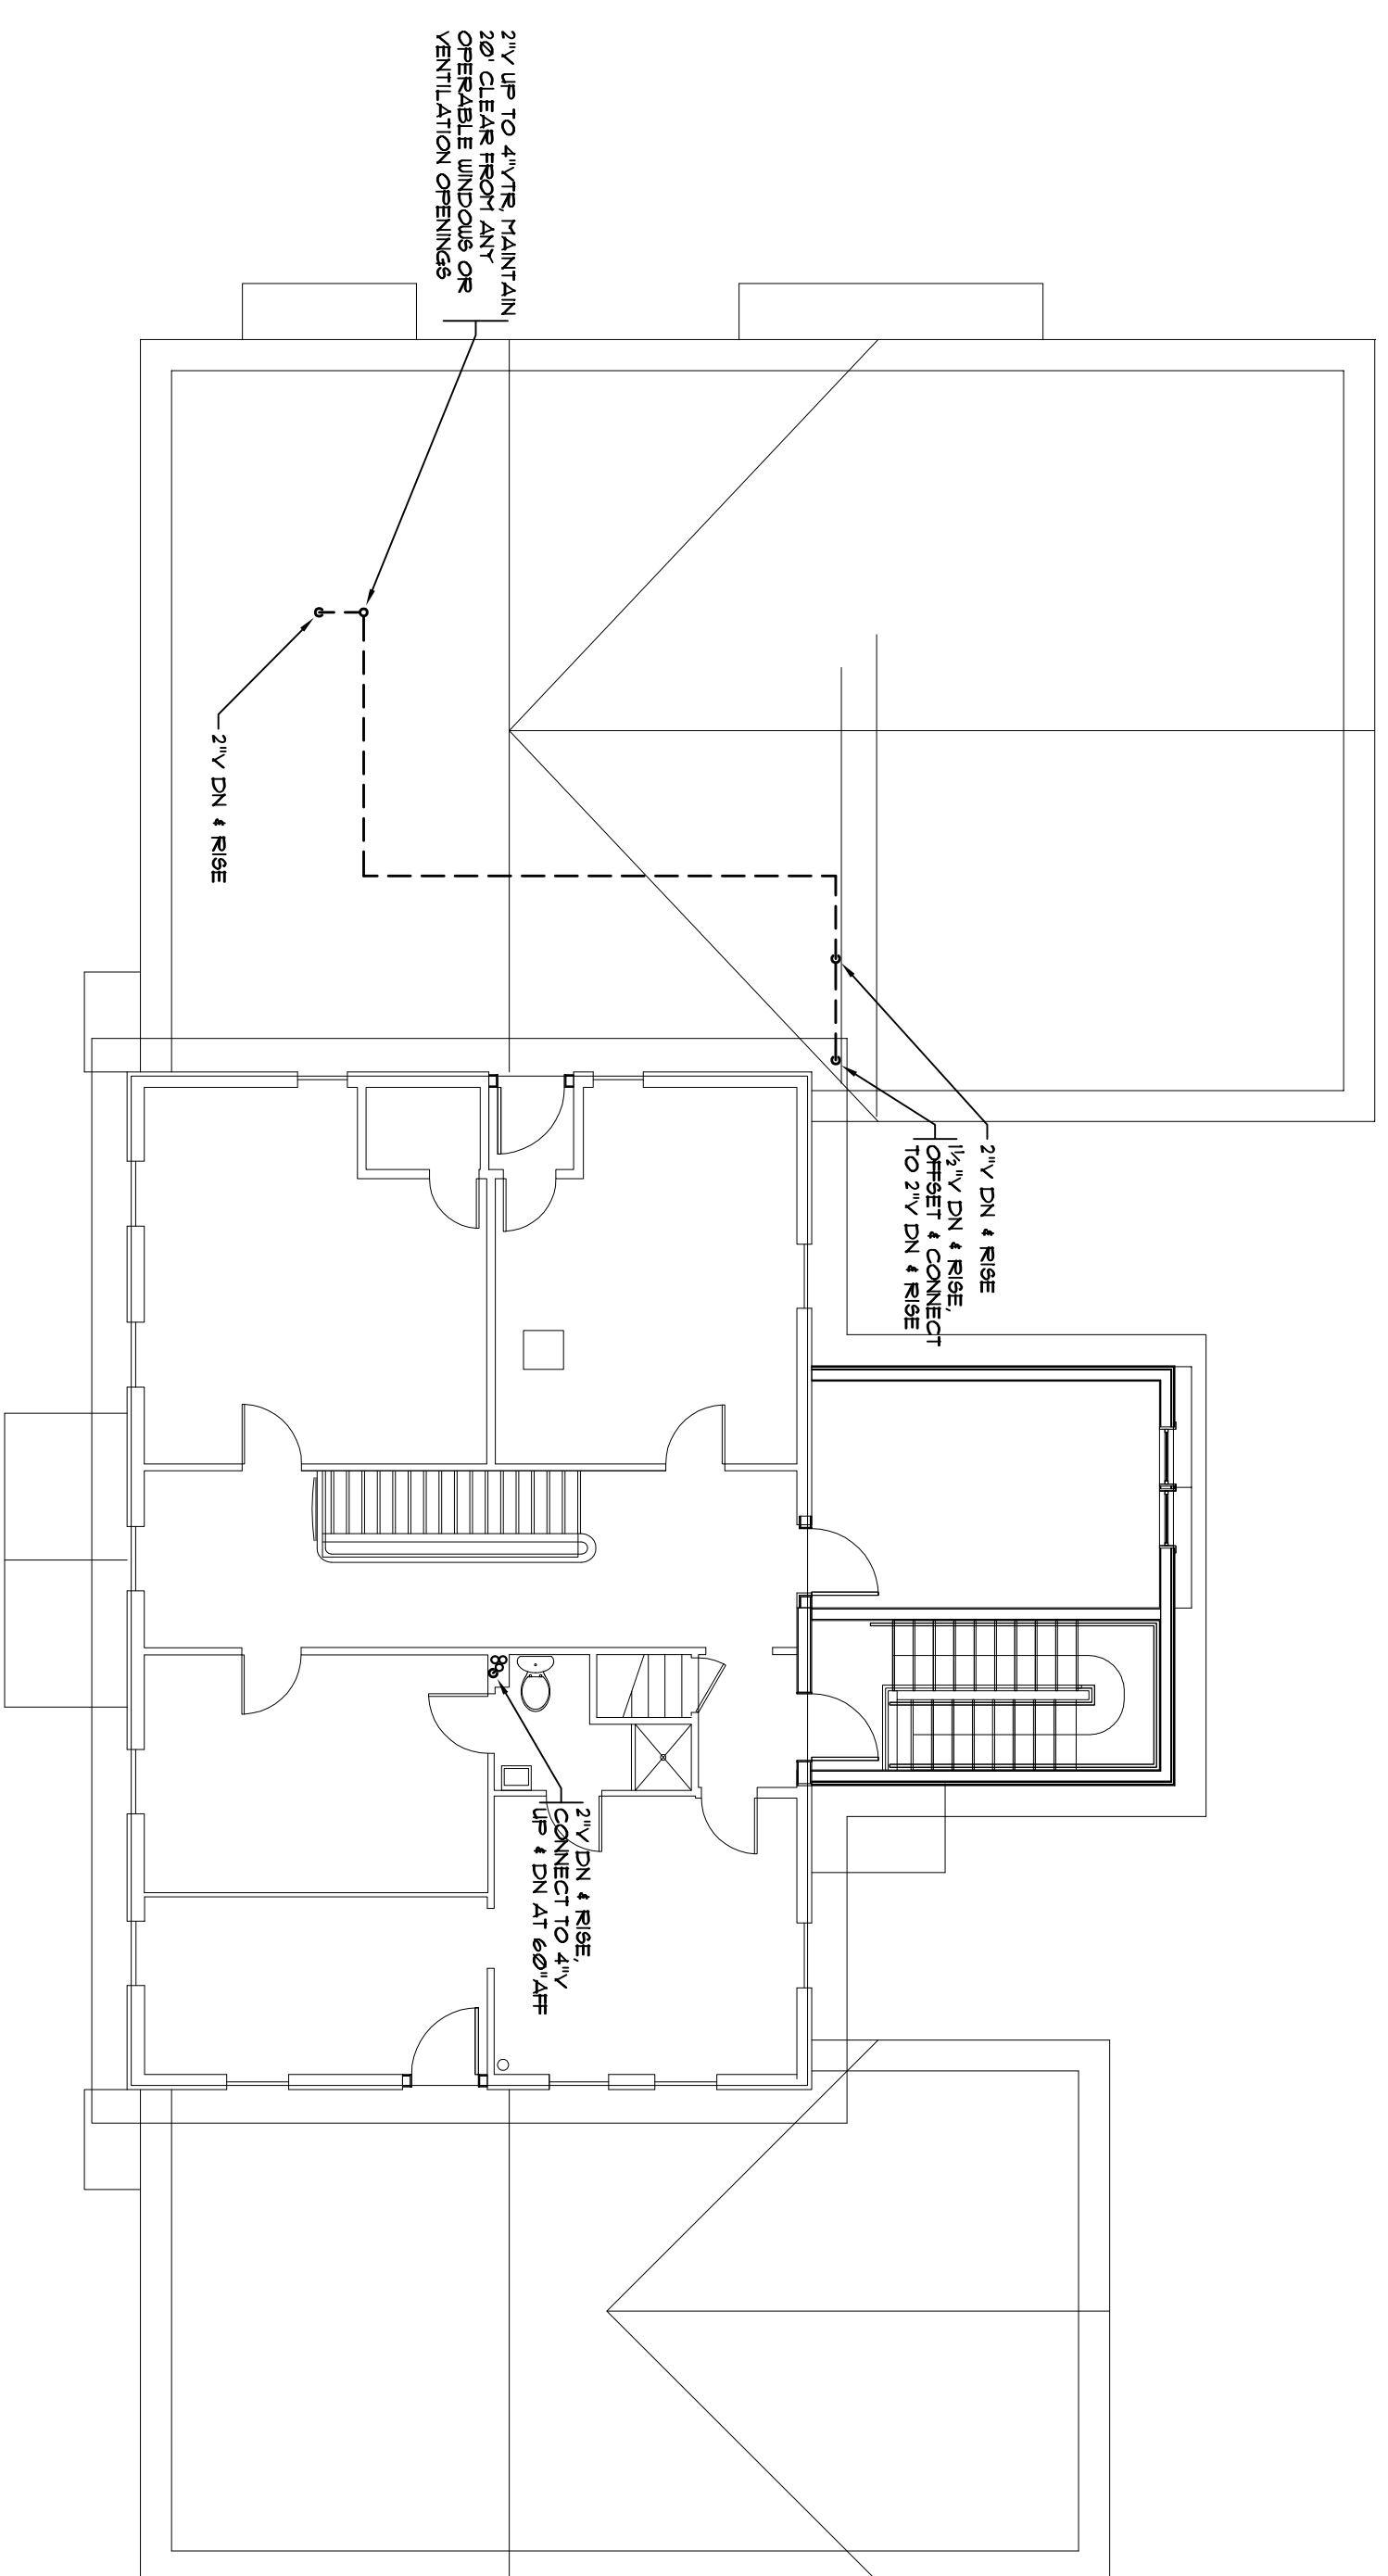

1 SECOND FLOOR PLAN
SCALE: 1/8" = 1'-0"

ARCHITECTURAL BUREAU
JOE IUVIENE AIA
P.O. BOX 238 - 29 MAIN STREET
CHATHAM NEW YORK 12037
(518) - 392 - 3650

PLUMB EXCEL GROUP
ENGINEERING, P.C.
29 British American Boulevard
Latham, New York 12110
PHONE: 518.464.0412 FAX: 518.464.0834

ADDITIONS RECONFIGURATION
AND RENOVATION
NEW LEBANON TOWN HALL
14755 Route 22
14755 Route 22
NEW LEBANON NY

SECOND & THIRD FLOOR
PLUMBING PLANS

REVISIONS

SCALE: AS NOTED
DRAWN BY: JED
DESIGNED BY: JED
CHECKED BY: DMH
DATE: 09-08-10

9/08/10

P2